


COBB COUNTY - MARIETTA WATER AUTHORITY

LOST MOUNTAIN WATER STORAGE TANK NO. 2

CCMWA PROJECT NO. 9005-04-62-0000

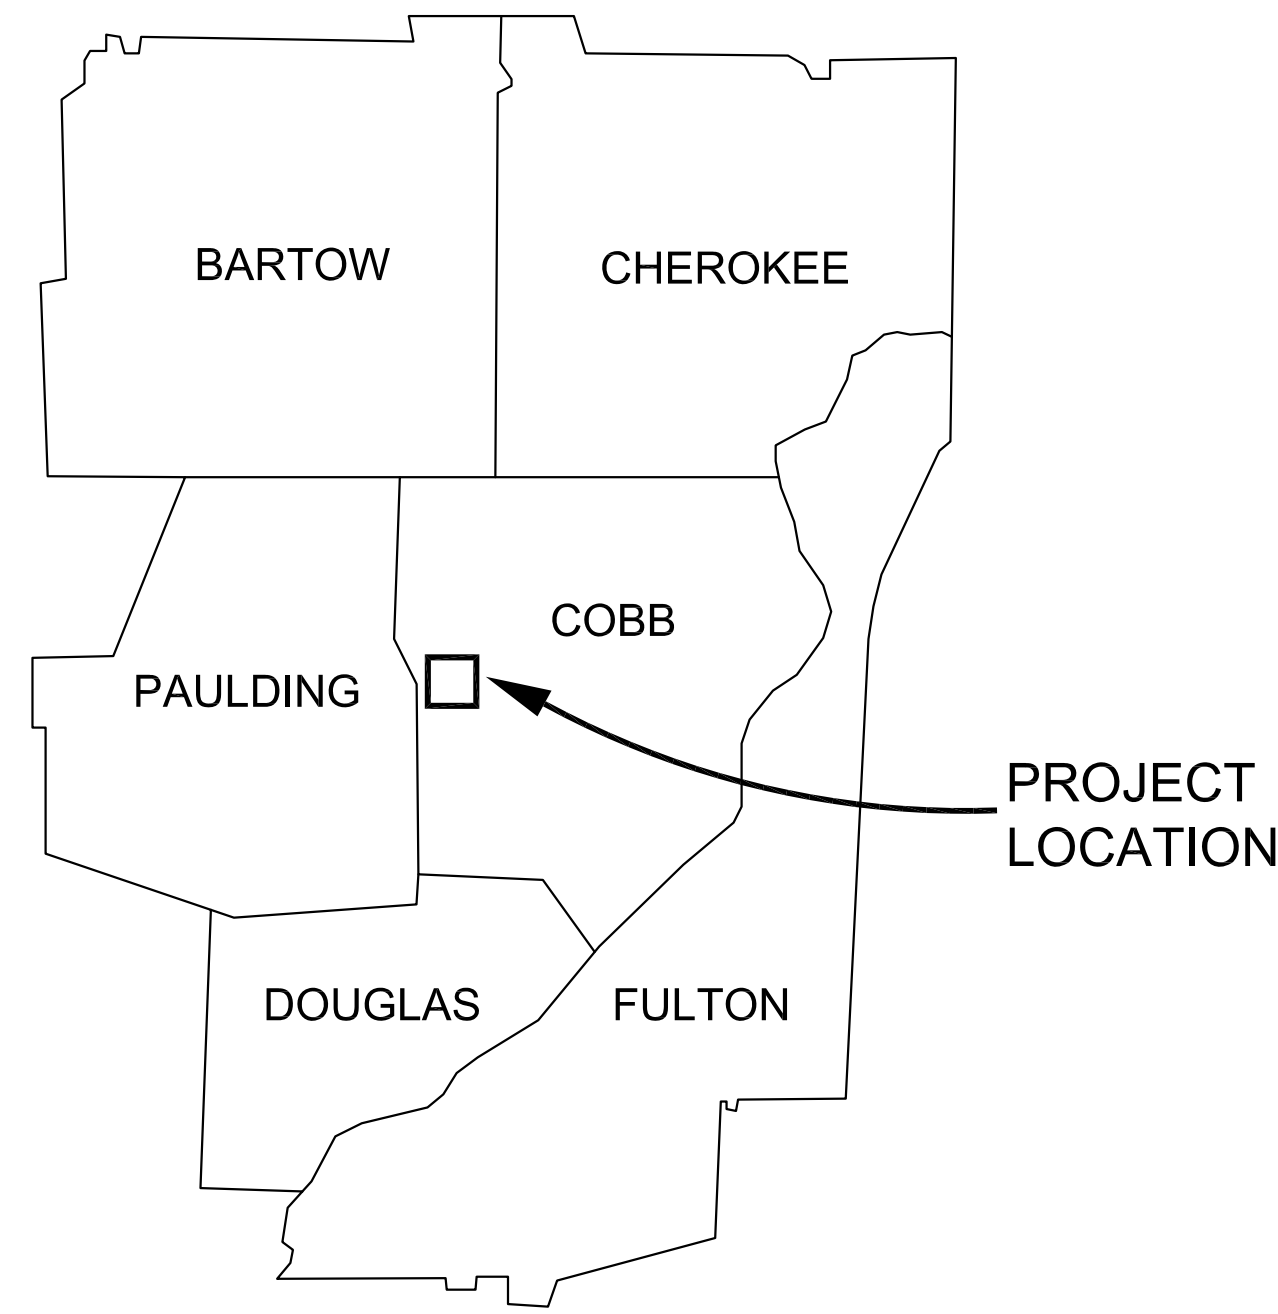

VICINITY MAP
NOT TO SCALE

Use October 1, 2014

AUGUST 1, 2014



Board Members


A. Max Bacon, Chairman
 David A. Austin, Vice-Chairman
 Charlie N. Crowder, Secretary
 T. Daniel Buyers, Member

Griffin "Grif" L. Chalfant Jr., Member
 Timothy D. Lee, Member
 James C. Scott Jr., Member

Glenn M. Page, P.E., General Manager
 George Kaffezakis, P.E., Direct of Engineering

CEC
 CIVIL ENGINEERING CONSULTANTS, INC.
 Civil & Environmental Engineering

4994 Lower Roswell Road, Suite 17
 Marietta, GA 30068
 (770) 977-5747
 www.cecincga.com

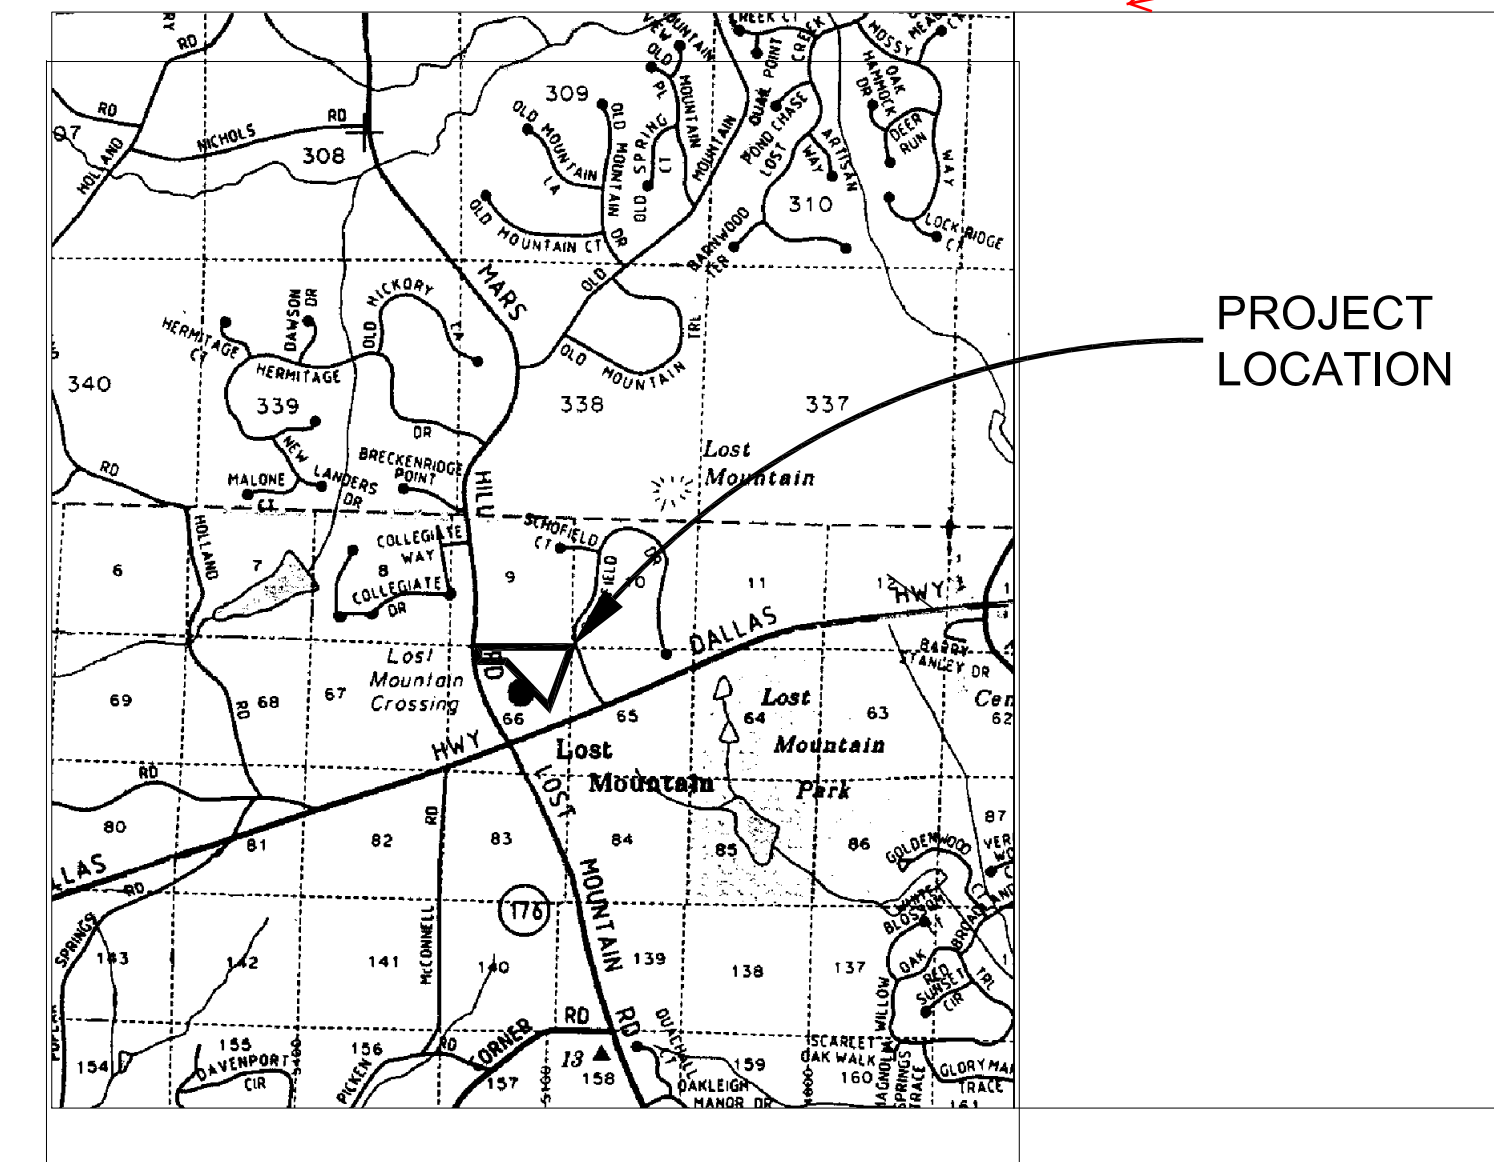

LOCATION MAP
SCALE: 1" = 1 MILE

PROJECT BID DATE: ~~Oct. 2014~~ November 19, 2014
 PROJECT COMPLETION DATE:
 CONTRACTOR:
 CONTRACTOR SUPERINTENDENT
 ENGINEER'S FIELD REPRESENTATIVE: TO NGUYEN
 CCMWA PROJECT MANAGER: JACOB WILSON

EMERGENCY CONTACT:
 JACOB WILSON
 COBB COUNTY - MARIETTA WATER AUTHORITY
 678-372-8158 (C)
 770-514-5300 (O)

INDEX OF DRAWINGS

SHEET NO.	DESCRIPTION
C1	COVER SHEET AND INDEX OF DRAWINGS
C2	OVERALL SITE PLAN
C3	TANK SITE PLAN
C4	GRADING PLAN
C5-C7	EROSION AND SEDIMENT CONTROL PLAN
C8	TREE PROTECTION PLAN
C9-C10	EROSION CONTROL NOTES AND DETAILS
C11	WATER MAIN DETAILS
T1	TANK PLAN
T2	TANK PROFILE
T3	WALL SECTION AND INLET AND DRAIN PIPE DETAILS
T4	OVERFLOW PIPE DETAILS
T5	TANK DETAILS
T6	LADDER DETAILS
T7	LEVEL INDICATOR AND ACCESS HATCH DETAILS

REVISIONS

DATE	REVISION